
 


ALL DIMENSIONS TO BE CHECKED ON SITE.
DO NOT SCALE FROM THIS DRAWING
EXCEPT FOR THE PURPOSES OF LOCAL AUTHORITY PLANNING

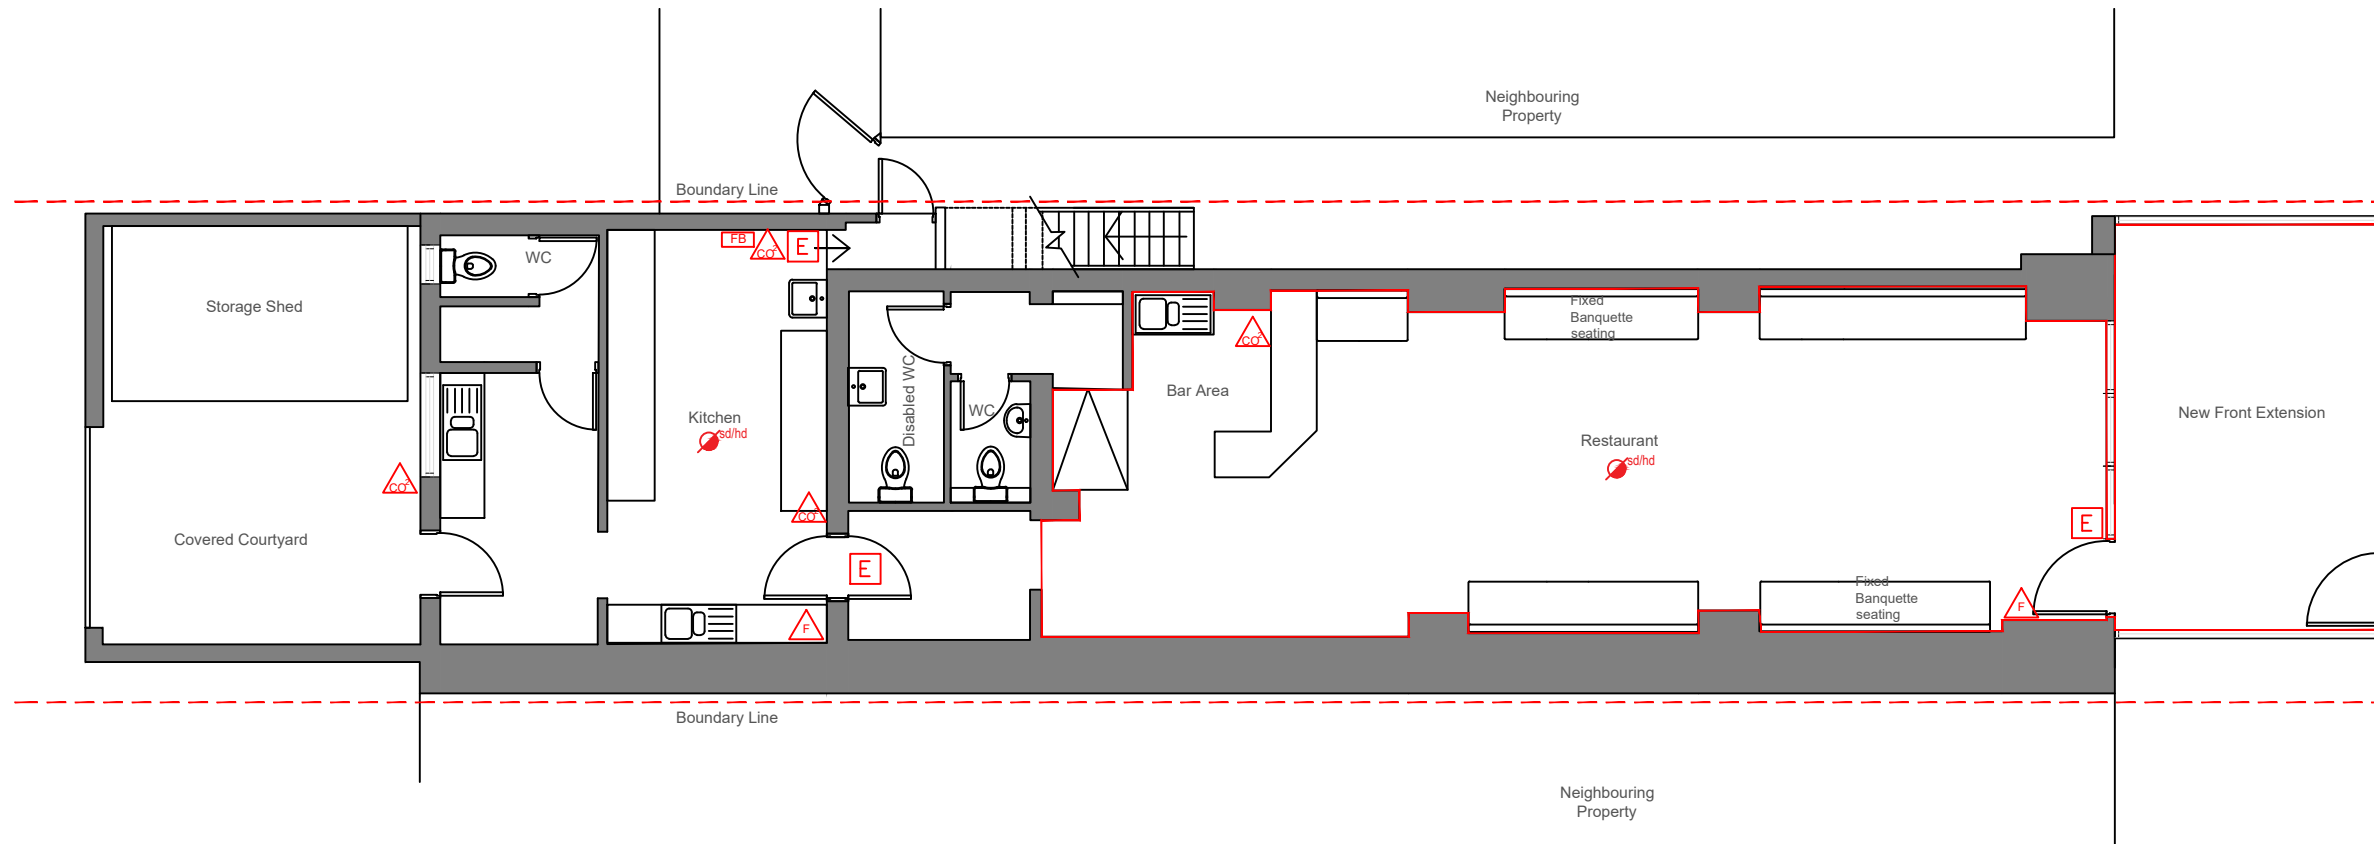

LEGEND	
	Smoke Detectors
	Fire Extinguisher (Carbon Dioxide)
	Fire Extinguisher (Foam)
	Escape sign with appropriate graphic and directional arrow
	Red outlined area for alcohol and late night refreshments zone
	Boundary Location

Ground Floor Plan
SCALE 1:100 @ A3



The copyright of this drawing is vested in the Designer and should not be reproduced, copied or used for any other purpose than that it is intended for without the prior written consent of Designed By Denisa.



Designed By Denisa
• Grays • RM162GB
Tel: 07717205285
Email: info@designedbydenisa.co.uk
www.designedbydenisa.co.uk

Contract
Desi Asia, 59 Orsett Rd, Grays

Client
Abdul Bashir

Sheet Title
Ground floor Licensing Plan

Date
NOV 2024

Scale
1:100 @ A3

Drawn By
DJ

Checked By

Drawing Number
100 - 001